



PROCUREMENT SERVICES

CITY OF SURREY, SURREY CITY HALL
13450 – 104 Avenue, Surrey, B.C., V3T 1V8
Tel: 604-590-7274
E-mail: purchasing@surrey.ca

ADDENDUM No. 2

REQUEST FOR QUOTATION No.:	1220-040-2024-033
TITLE:	HVAC UPGRADE, SPS
ADDENDUM ISSUE DATE:	JUNE 18, 2024
CLOSING DATE AND TIME:	PREFER TO RECEIVE SUBMISSION ON OR BEFORE JUNE 27, 2024

INFORMATION FOR CONTRACTORS

Contractors are advised that Addendum No. 2 to 1220-040-2024-033 is hereby issued by the City. This addendum shall form part of the contract documents and is to be read, interpreted and coordinated with all other parts. The following information is provided to answer questions raised by Contractors, for the above-named project, to the extent referenced and shall become a part thereof. No consideration will be allowed for extras due to the Contractors or any sub-contractor not being familiar with this addendum. This Addendum No. 2 contains one (1) page.

REVISED DATE:

Delete Section 3 in its entirety and substitute with Section 3 below:

3. DATE

The City would prefer to receive Quotations on or before June 27, 2024 (the “**Date**”).

QUESTIONS AND ANSWERS:

Q1. Could you please provide information on the replacement of TRU-5 zone control valve

A1. **Please see the drawing attached to this addendum.**

All Addenda will become part of the Contract Documents.

- END OF ADDENDUM -

TO	PROJECT	NO. OF PAGES	DISTRIBUTION
City of Surrey	SPS Training Centre HVAC Upgrade	1 Page(s)	<input checked="" type="checkbox"/> Owner
Corporate Services	14577 66 th Ave	DATE ISSUED	<input checked="" type="checkbox"/> Gen. Contractor
6651 – 148 th Street	Surrey, BC	June 17, 2024	<input checked="" type="checkbox"/> Mech. Contractor
Surrey, BC		PROJECT NO.	<input type="checkbox"/> Elect. Contractor
RE	ISSUED BY	24-028	<input type="checkbox"/> Resident Eng.
Zone Control Dampers Separate Price	Lovejit Buttar	CONTRACT	<input checked="" type="checkbox"/> File
		Mechanical	<input checked="" type="checkbox"/> Other

1 GENERAL

- .1** This Addendum is issued prior to the closing of tenders to provide revisions or clarifications to the Work. The revisions and clarifications covered by this addendum shall be carried out in accordance with the requirements of the Specifications. The following addendum items shall become part of the Contract Documents.
- .2** Attachments:
 - Mechanical Drawings

2 ZONE CONTROL DAMPER SEPARATE PRICE

- .1** Contractor to provide a separate price for the replacement of existing zone control dampers with new 8"Ø EH Price SDV. Units are to be 120V/1ph. Contractor to allow for the provision of a bypass complete with all associated ductwork. Bypass is to be provided a 12"Ø EH Price SDV. Allow for the provision of a Delta controller to allow for control of system. Delta controller is to be provided standalone controls with future DDC integrations.

End of Document

FLOW ENGINEERING

1080-1075 W Georgia St Phone: (604) 609-0500
 Vancouver, BC V6E 3C9 hello@flowengineering.ca
 Permit to Practice: #1001816 flowengineering.ca

Copyright

This drawing is the property of the Designer and may not be reproduced or used without the expressed consent of the Designer. All information shown on this drawing is for use on this project only and shall not be used otherwise. The Contractor is responsible for checking and verifying all levels and dimensions and shall report all discrepancies to the Designer and obtain clarification prior to commencing work. Do not scale the drawings.

Stamp/seal

Revisions

No.	Date	Details	By
00	2024/03/14	Issued for Review	LB
01	2024/05/03	Issued for Review	LB
02	2024/05/15	Issued for Review	LB
03	2024/05/17	Issued for Pricing	LB
04	2024/06/17	Issued for ADD-M1	LB

Project

SURREY POLICE SERVICE (SPS) TRAINING CENTRE HVAC UPGRADE

14577 66TH AVE,
SURREY, BC

Date: FEBRUARY 29, 2024

Drawing Title

2ND FLOOR COOLING


Project no.: 24-028 Scale: AS NOTED

Drawn: LB Approved: BY

Drawing no.

M-3

WAREHOUSE

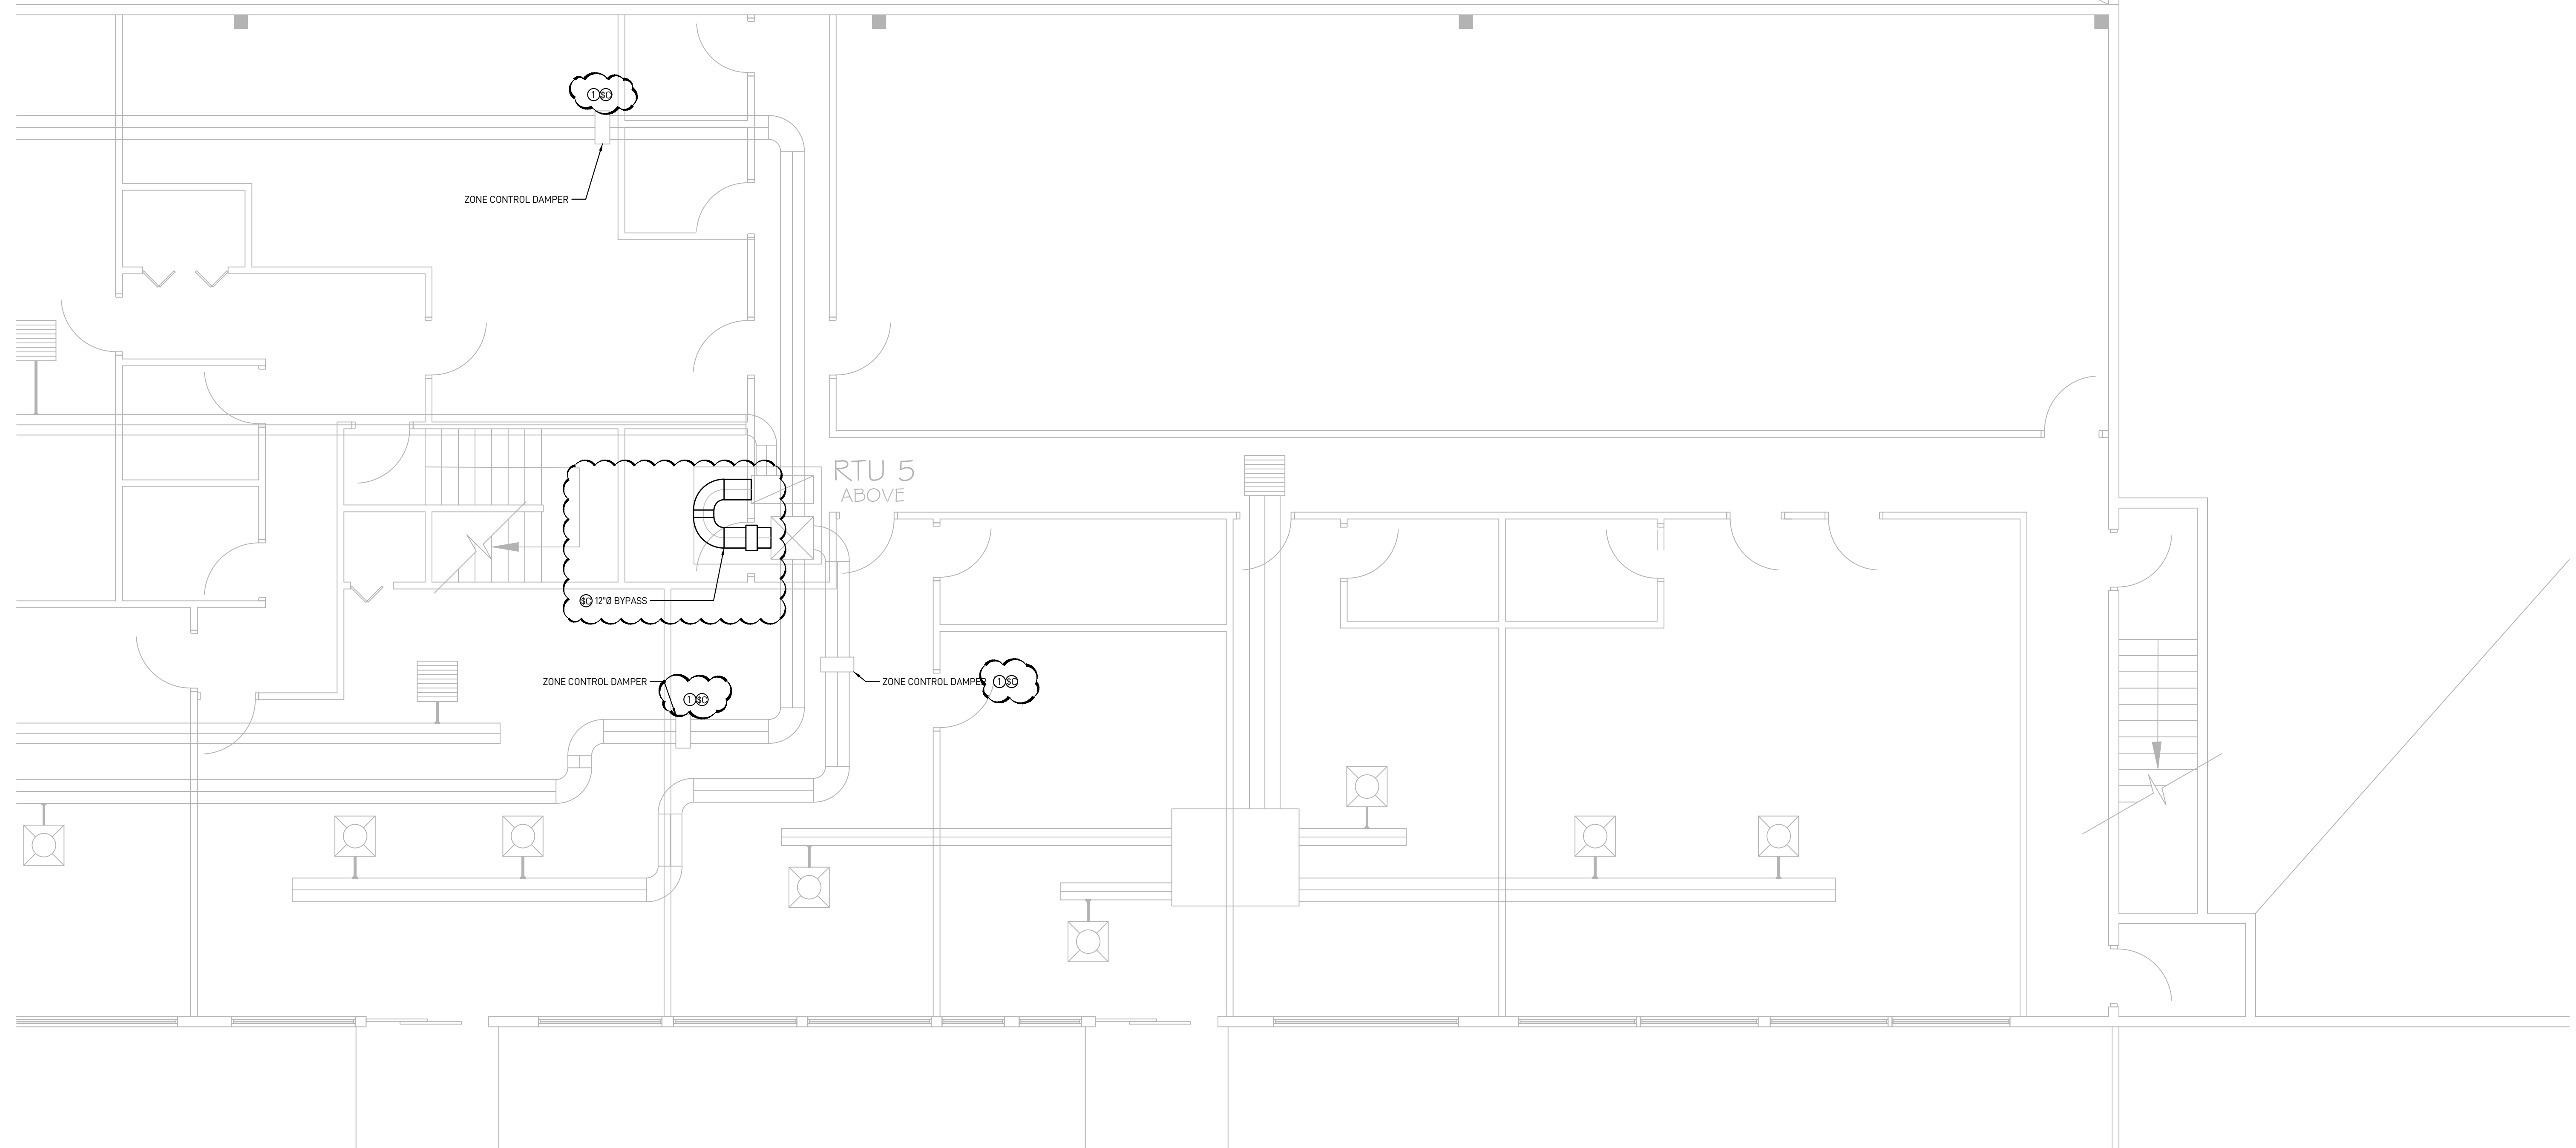

CONSTRUCTION NOTES
NEW

① CONTRACTOR TO ALLOW FOR TESTING THE OPERATIONS AND REPORTING THE SEQUENCE OF OPERATIONS OF THE EXISTING ZONE DAMPERS.

TYP. ② MECHANICAL CONTRACTOR TO RETAIN AN ELECTRICAL CONTRACTOR TO COMPLETE ALL ASSOCIATED ELECTRICAL WORK.

SEPARATE PRICE

③ CONTRACTOR TO PROVIDE A SEPARATE PRICE FOR THE REPLACEMENT OF EXISTING ZONE CONTROL DAMPERS WITH NEW 8"Ø EH PRICE SDV. UNITS ARE TO 120V/1PH. CONTRACTOR TO ALLOW FOR THE PROVISION OF A BYPASS COMPLETE WITH ALL ASSOCIATED DUCTWORK. BYPASS IS TO BE PROVIDED A 12"Ø EH PRICE SDV. ALLOW FOR THE PROVISION OF A DELTA CONTROLLER TO ALLOW FOR CONTROL OF SYSTEM. DELTA CONTROLLER IS TO BE PROVIDED STANDALONE CONTROLS WITH FUTURE DDC INTEGRATIONS.